


**KEY:**

- ⊕ SWITCH
- ⊕ DUPLEX OUTLET
- ⊕ FLOOR OUTLET
- ⊕ COUNTER HEIGHT
- ▽ TELEPHONE/ETHERNET
- ⊠ THERMOSTAT
- EXHAUST FAN
- OVERHEAD LIGHT
- ▭ STRIP LIGHT
- ⊕ FAN

**NOTE:**

- ▨ WALL HEIGHTS: 11'-11"
- NO CEILING, OPEN ABOVE

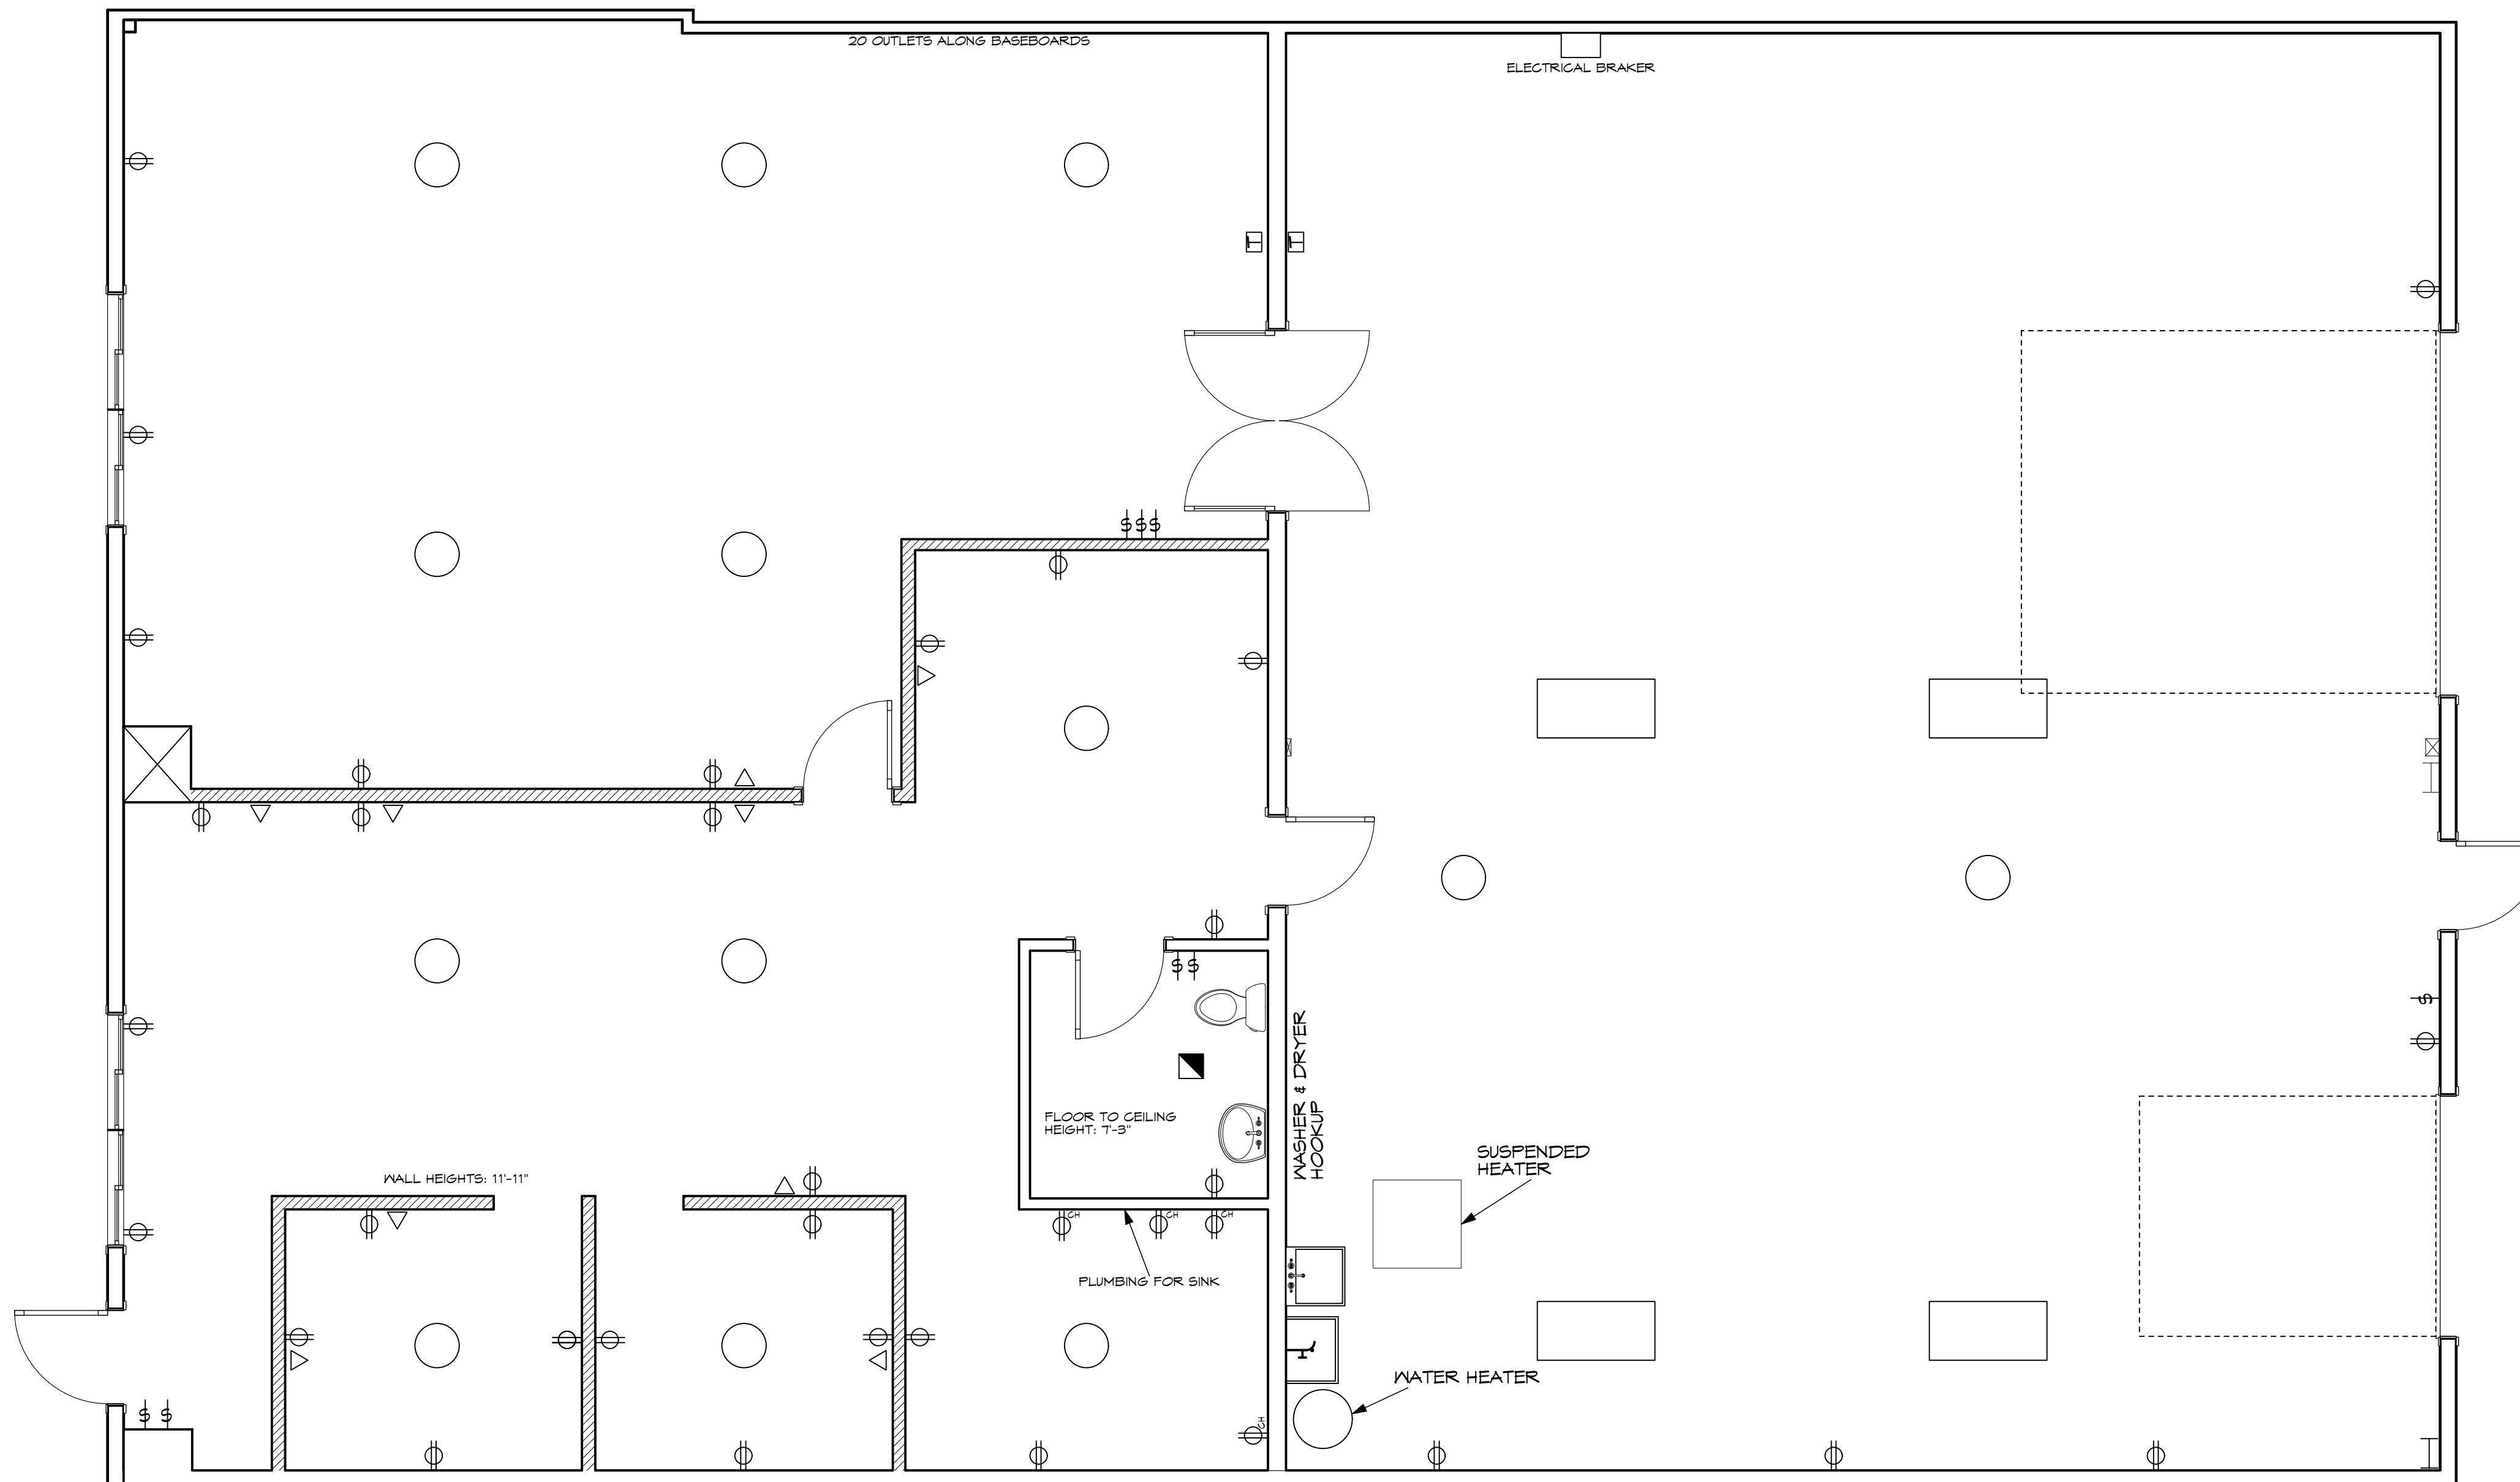

1 FLOOR FLOOR PLAN  
Scale: 1/4" = 1'-0"

DATE:

REV.:

SCALE:  
AS NOTED  
DRAWN BY:  
CFB

O'BRIEN BROTHERS AGENCY

UNIT 4, 1366 MARSHALL AVE.  
WILLISTON, VT 05495

O'BRIEN  
BROTHERS  
AGENCY INC

1366 WILLISTON ROAD  
SOUTH BURLINGTON, VT 05403  
802-895-0000  
www.obrienbrothersagency.com

FLOOR PLAN

A-1

1366 MARSHALL AVE.

© O'BRIEN BROTHERS AGENCY, INC.